


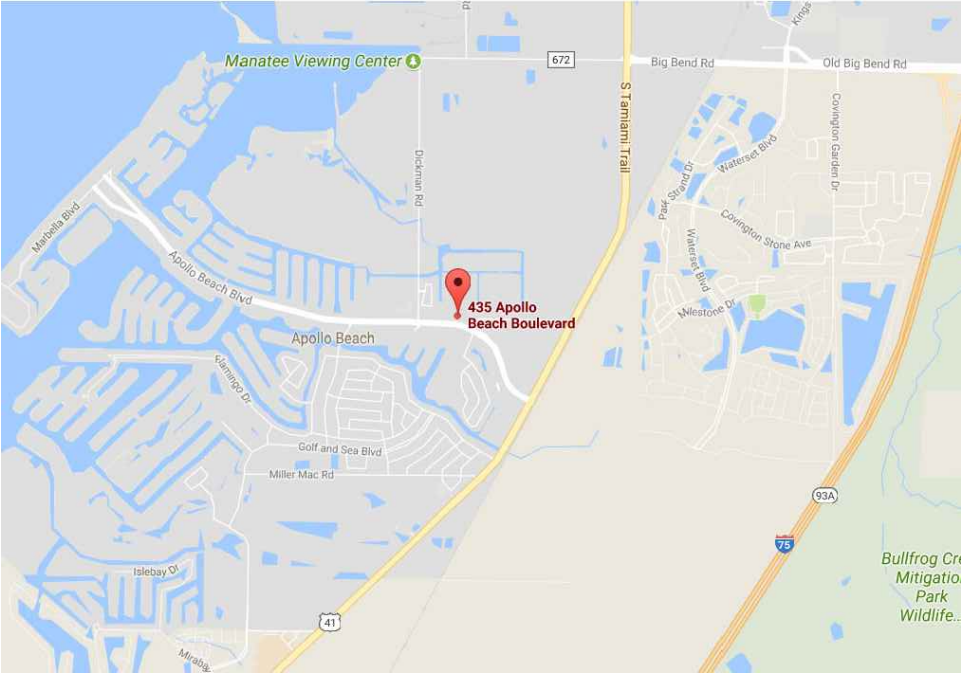

Area Map



Aerial Photograph



Existing Site Photograph



360 Photo / As-Built Survey

Project Name

FCID

N/A


Address

Project Total S.F.

1,945



Arktech Solutions LLC
10804 Inside Loop
Orlando, FL 32825
P 214 606 5281
www.arktechsolution.com

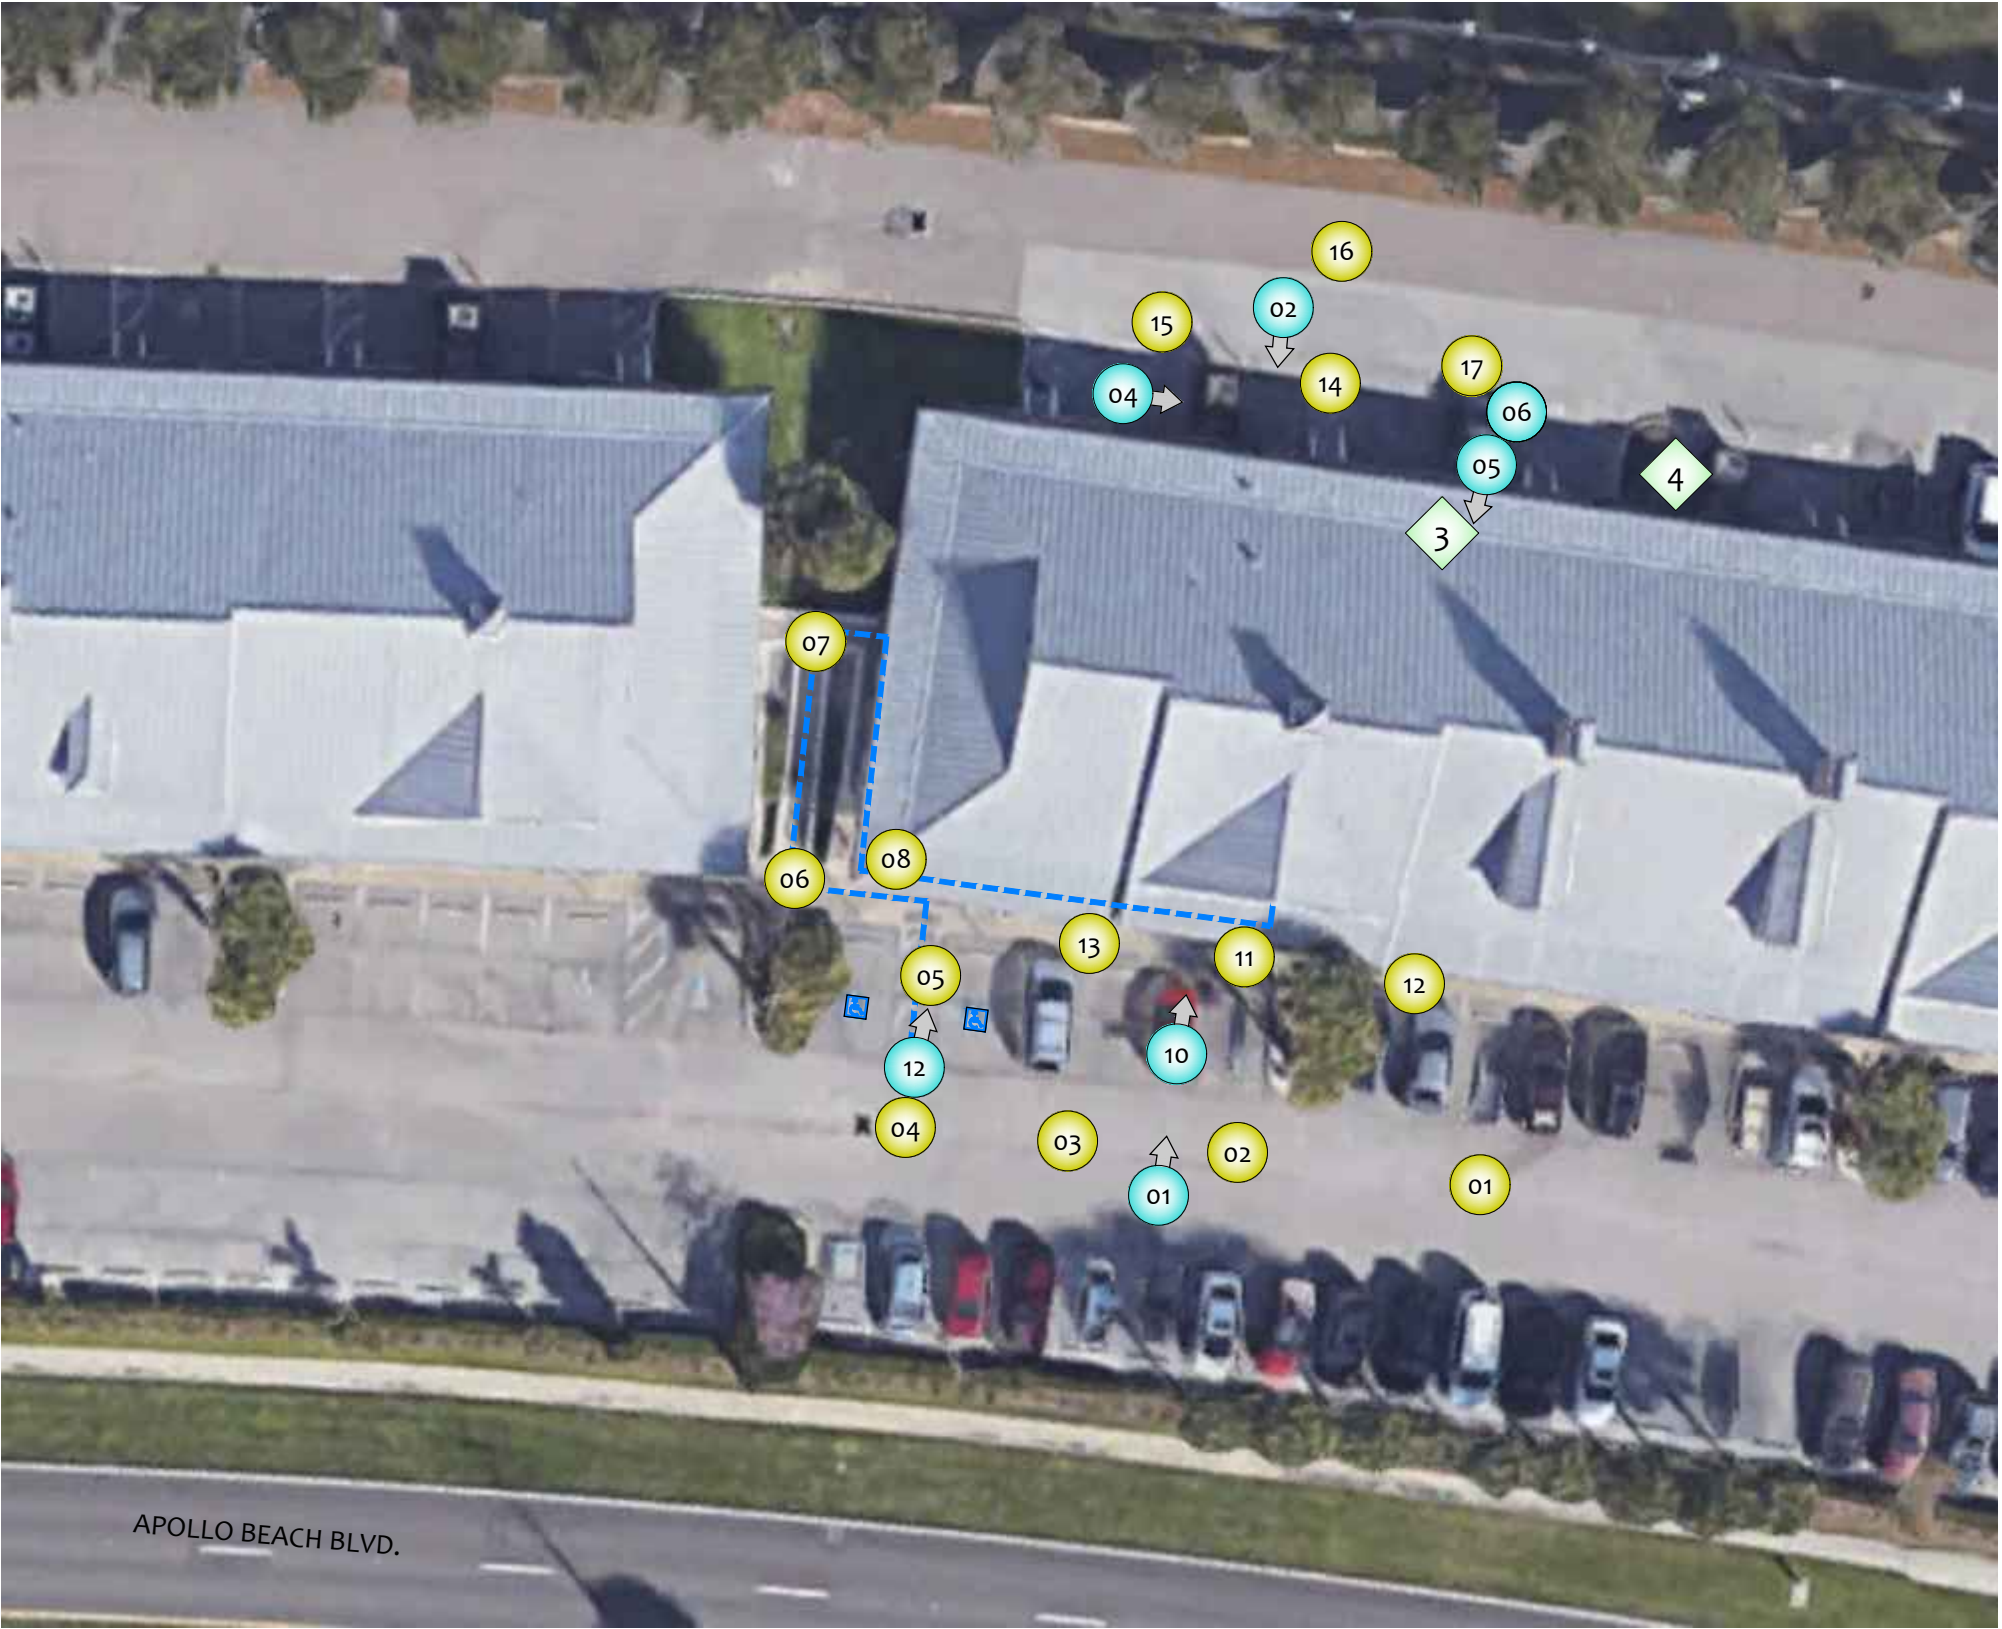

APOLLO BEACH BLVD.



SCALE: NTS

- 1 GAS MAIN & METER
- 2 WATER MAIN & METER
- 3 ELECTRIC MAIN & METER
- 4 ELEC. TRANSFORMER

5 FIRE DEPT. CONNECTION (RISER)

*NOTE: NOT ALL KEYNOTES MAY BE USED. SEE DRAWING FOR APPLICABLE ITEMS.



ACCESSIBLE PARKING STALL



ACCESSIBLE PATH OF TRAVEL

01 360 Vantage Point

01 Still Photo

01 Red Flag Notification


OWNER:

CLIENT:



Arktech Solutions LLC.
10804 Inside Loop
Orlando, FL 32825
tel: (214) 606-5281
www.Arktech.org

FC NAME:		----
FCID:		N/A
FC ADDRESS:		----- ----- -----
FIELD SURVEYOR:		----
PROJECT DIRECTOR:		----
CHECKED BY:		----
DATE COMPLETED:		08-02-2017
PROJECT NUMBER:		----
SHEET:		SP01
DRAWING NUMBER:	OF:	026
DRAWING NAME:		SITE PLAN

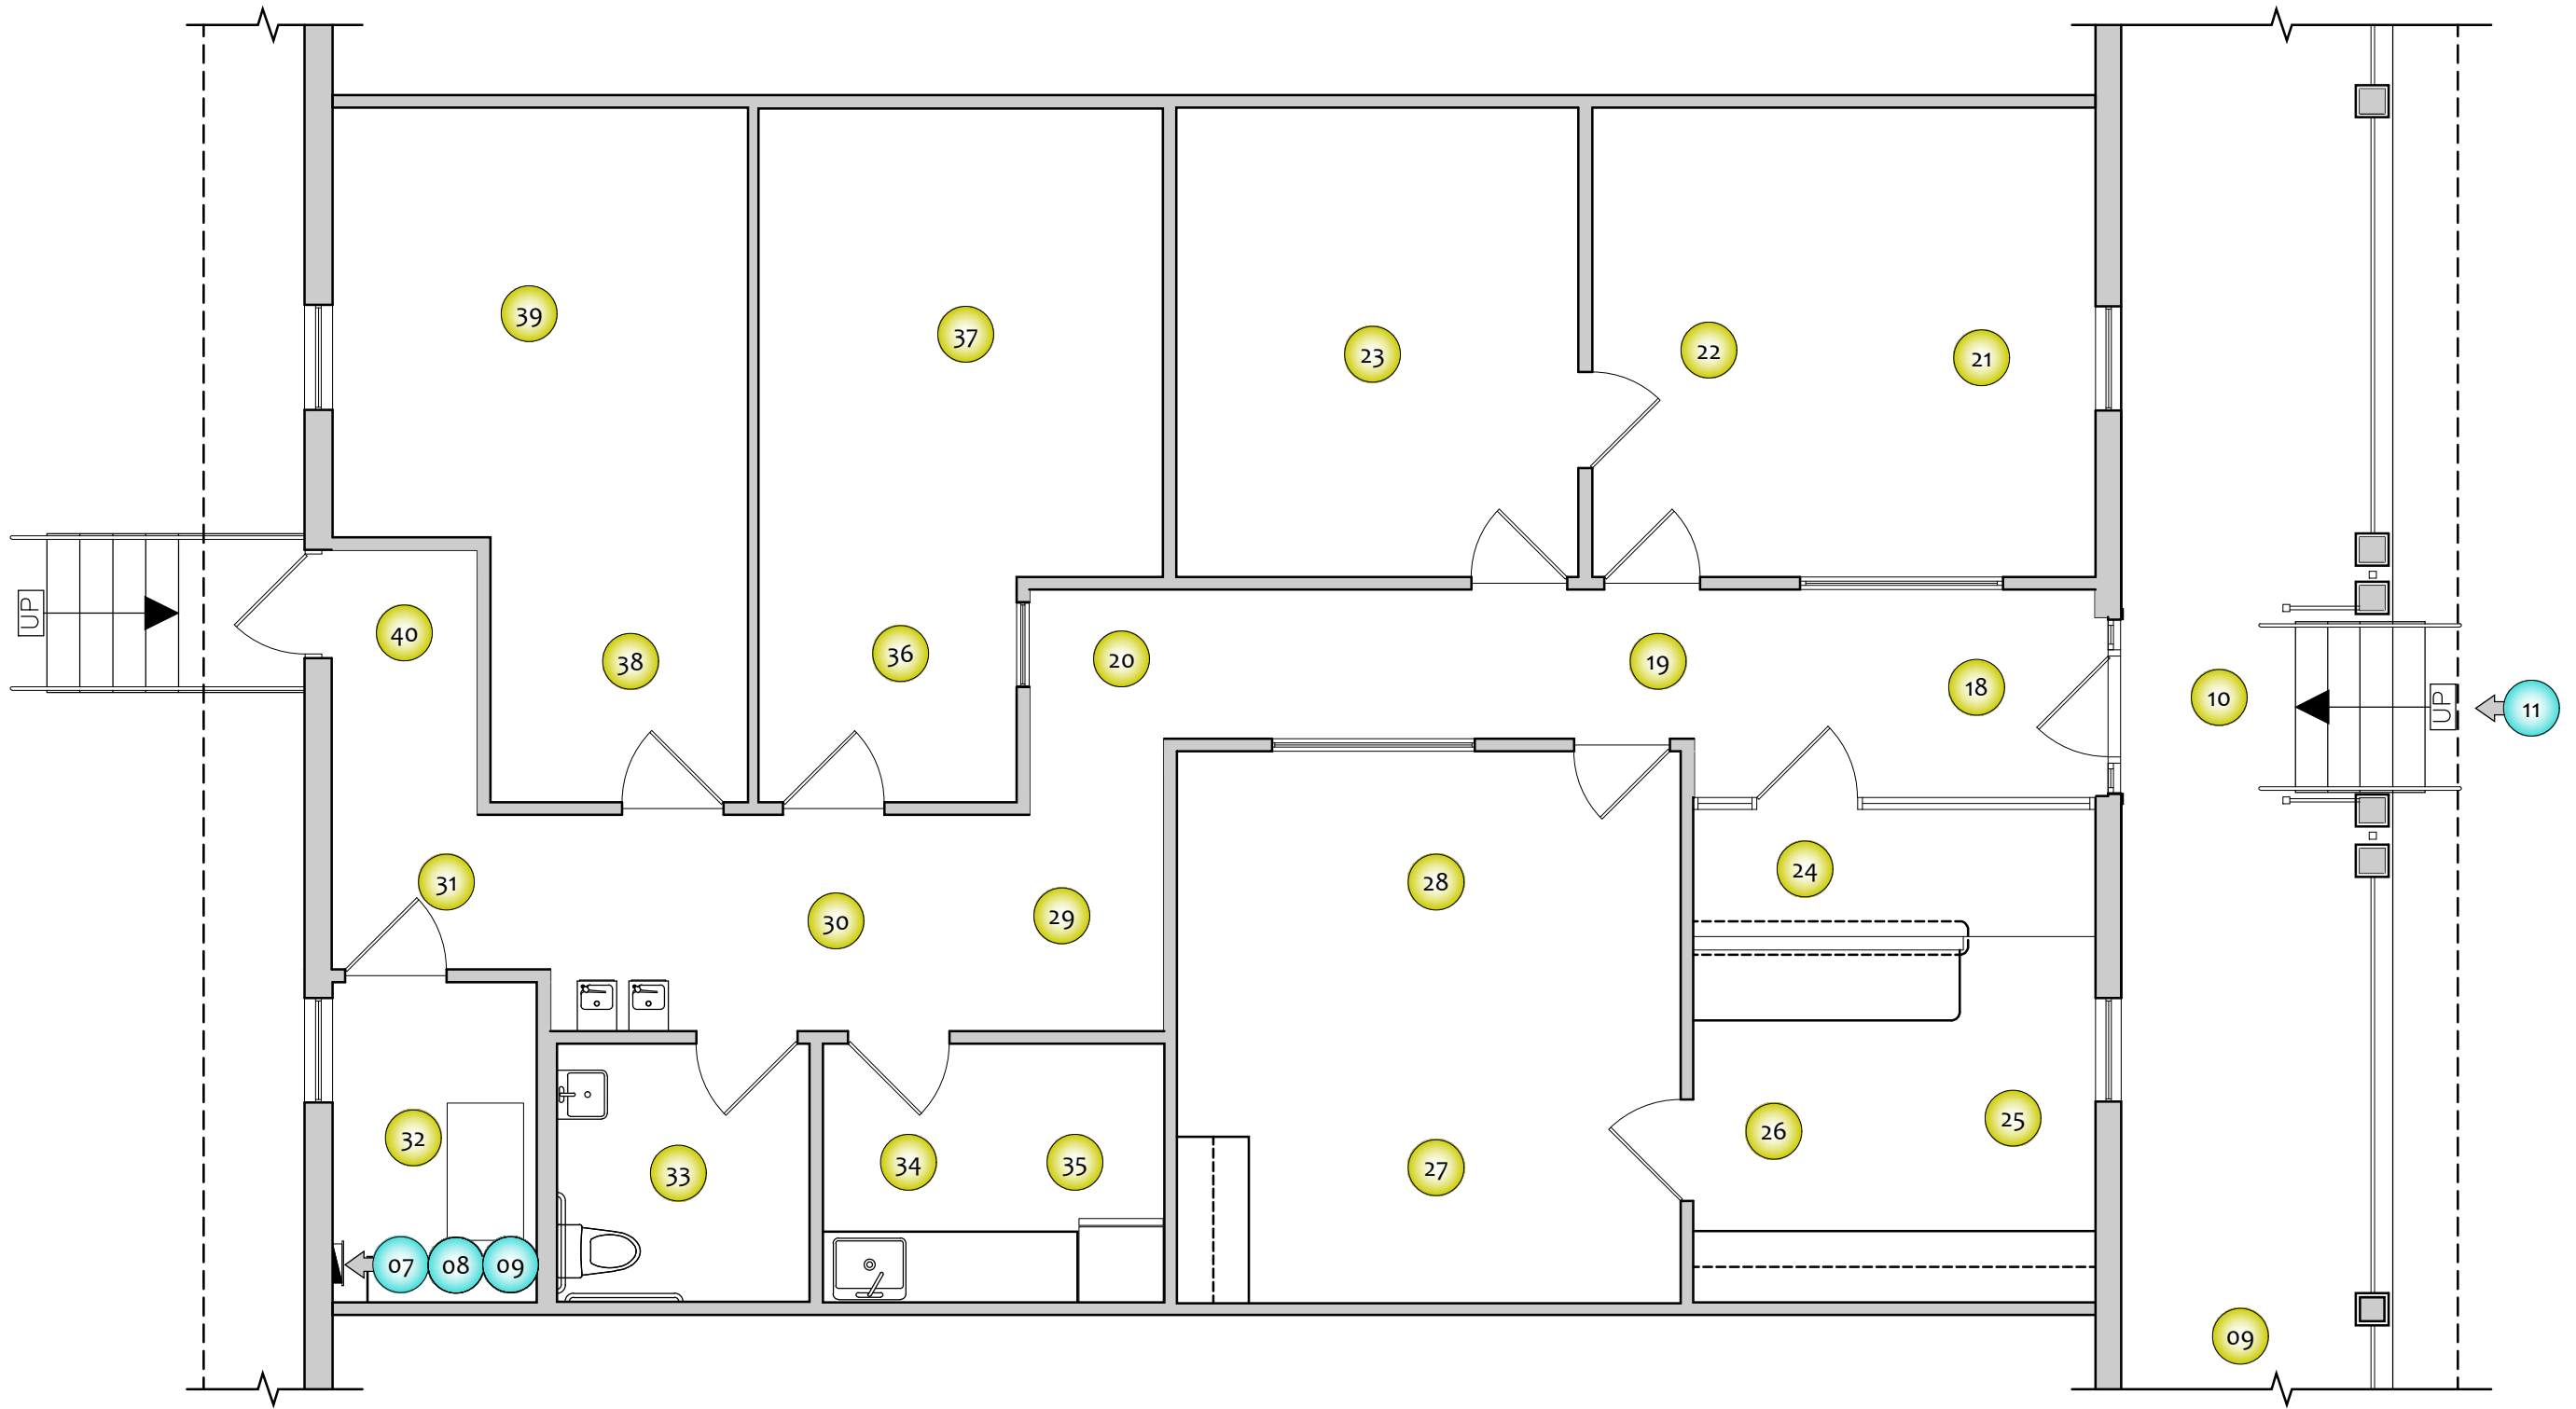

5' 7.5' 10'
SCALE: 3/16" = 1'-0"

01 360 Vantage Point

01 Still Photo

01 Red Flag Notification

OWNER:

CLIENT:




Arktech Solutions LLC
10804 Inside Loop
Orlando, FL 32825
tel: (214) 606-5281
www.Arktech.org

FC NAME:	----
FCID:	N/A
FC ADDRESS:	----- ----- -----

FIELD SURVEYOR:	----
PROJECT DIRECTOR:	----
CHECKED BY:	----
DATE COMPLETED:	08-02-2017

PROJECT NUMBER:	----
SHEET:	A001
DRAWING NUMBER:	04
OF:	6

DRAWING NAME:	360 PHOTO PLAN
---------------	----------------

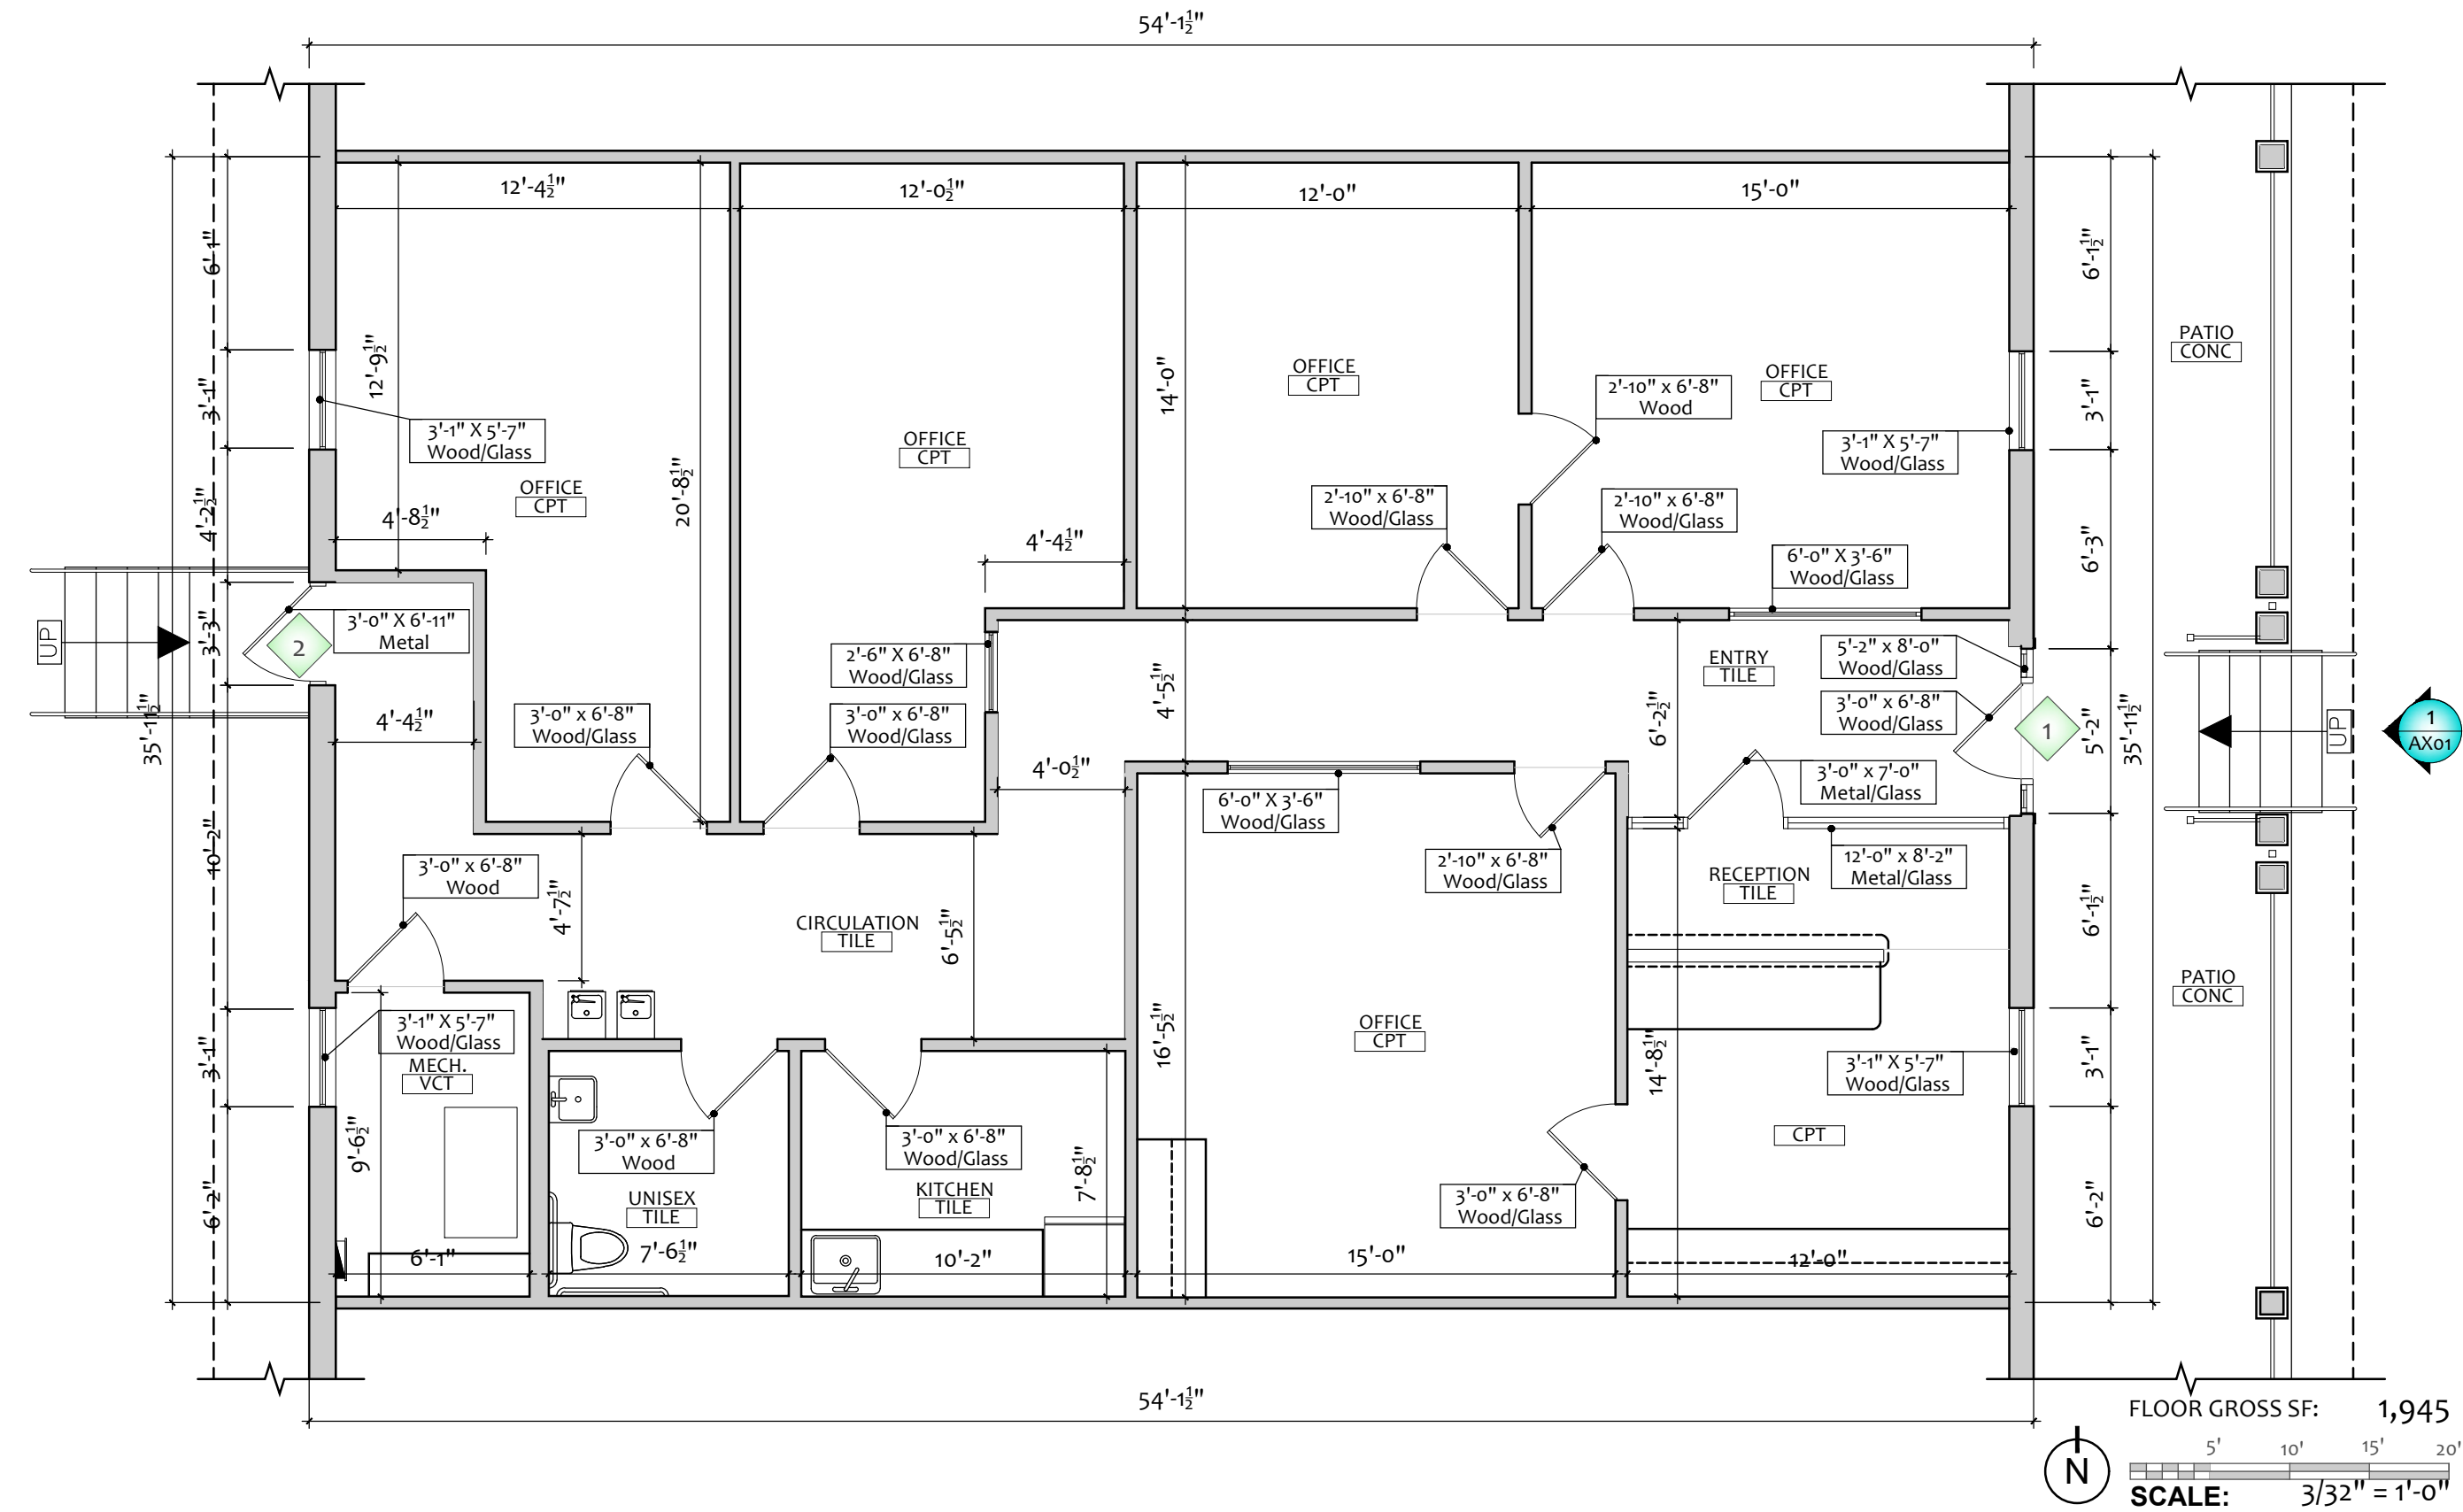

- 1 BUILDING ENTRANCE
- 2 EMERGENCY/ ALARMED EXIT DOOR

- CPT CARPET
- TILE TILE
- WOOD WOOD
- S-LIN LINOLEUM SHEET
- MAT FLOOR MAT
- VCT VINYL COMP. TILE
- CONC CONCRETE

- ⊕ DUPLEX OUTLET
- ⊕ QUAD PLEX OUTLET
- ▼ DATA OUTLET
- ▼ DATA/ TELEPHONE
- ▽ TELEPHONE
- ⊕ DUPLEX - FLOOR
- ⊕ QUADPLEX - FLOOR
- ▼ DATA - FLOOR
- ▼ DATA / TELE - FLOOR
- Ⓣ THERMOSTAT
- Ⓢ FIRE EXTINGUISHER
- Ⓢ FIRE HOSE
- Ⓢ LIGHT SWITCH

- SCP SEC. CONT'L. PANEL
- MONITOR
- AV AV OUTLET
- ELEC PANEL - RECESSED
- ELEC PANEL - SURFACE
- GENERATOR ELEC GENERATOR

- C CARD READER
- K KEYPAD LOCK
- P PULL STATION
- V FIRE CUT-OFF VALVE
- DRINKING FOUNTAIN

- VAULT VCT
- COLUMN SIZE 6.5" X 6.5" @ 32'-0" O.C.

ROOM NAME & FLOORING MATERIAL



INTERIOR ELEVATIONS



EXTERIOR ELEVATIONS

OWNER:

CLIENT:



Arktech Solutions LLC.
10804 Inside Loop
Orlando, FL 32825
tel: (214) 606-5281
www.Arktech.org

FC NAME:	----
FCID:	N/A
FC ADDRESS:	----- ----- -----

FIELD SURVEYOR:	----
PROJECT DIRECTOR:	----
CHECKED BY:	----
DATE COMPLETED:	08-02-2017

PROJECT NUMBER:	----
SHEET:	A002
DRAWING NUMBER:	05
OF:	6

DRAWING NAME:	FLOOR PLAN
---------------	------------



ACT
GYP BD
STRUCT
CONC
METAL
WOOD
ACT DIR
APP

CEILING TILE
GYPSUM BOARD
STRUCTURE
CONCRETE
METAL
WOOD
CEILING TILE,
DIRECT-APPLIED

DUPLEX - CEILING	SMOKE DETECTOR	MOTION SENSOR - CEILING
QUADPLEX - CEILING	FIRE SPRINKLER	MOTION SENSOR - WALL
DATA - CEILING	EMERGENCY LIGHT	FIRE STROBE
DATA / TELE - CEILING	FIRE HORN/ALARM	SURVEILLANCE CAMERA
SPEAKER	MONITOR	CAMERA BUBBLE
	EXIT SIGN	

2 x 4 FLUORESCENT FIXTURE	RECESSED CAN LIGHT	SUPPLY AIR REGISTER
2 x 2 FLUORESCENT FIXTURE	ADJUSTABLE CAN LIGHT	RETURN AIR REGISTER
FLUORESCENT FIXTURE	PENDANT LIGHT	SUPPLY REGISTERS
UTILITY FLUORESCENT FIXTURE	WALL SCONCE	VENT
TRACK LIGHT FIXTURE	SURFACE MOUNTED LIGHT	CEILING FAN

CLG HT
8'-0"
ACT


HEIGHT OF CEILING
FROM FLOOR &
CEILING MATERIAL

OWNER:


CLIENT:

Arktech Solutions LLC.
10804 Inside Loop
Orlando, FL 32825
tel: (214) 606-5281
www.Arktech.org

FC NAME:	----
FCID:	N/A
FC ADDRESS:	----- ----- -----
FIELD SURVEYOR:	----
PROJECT DIRECTOR:	----
CHECKED BY:	----
DATE COMPLETED:	08-02-2017
PROJECT NUMBER:	----
SHEET:	A003
DRAWING NUMBER:	06
OF:	6
DRAWING NAME:	REFLECTED CEILING PLN

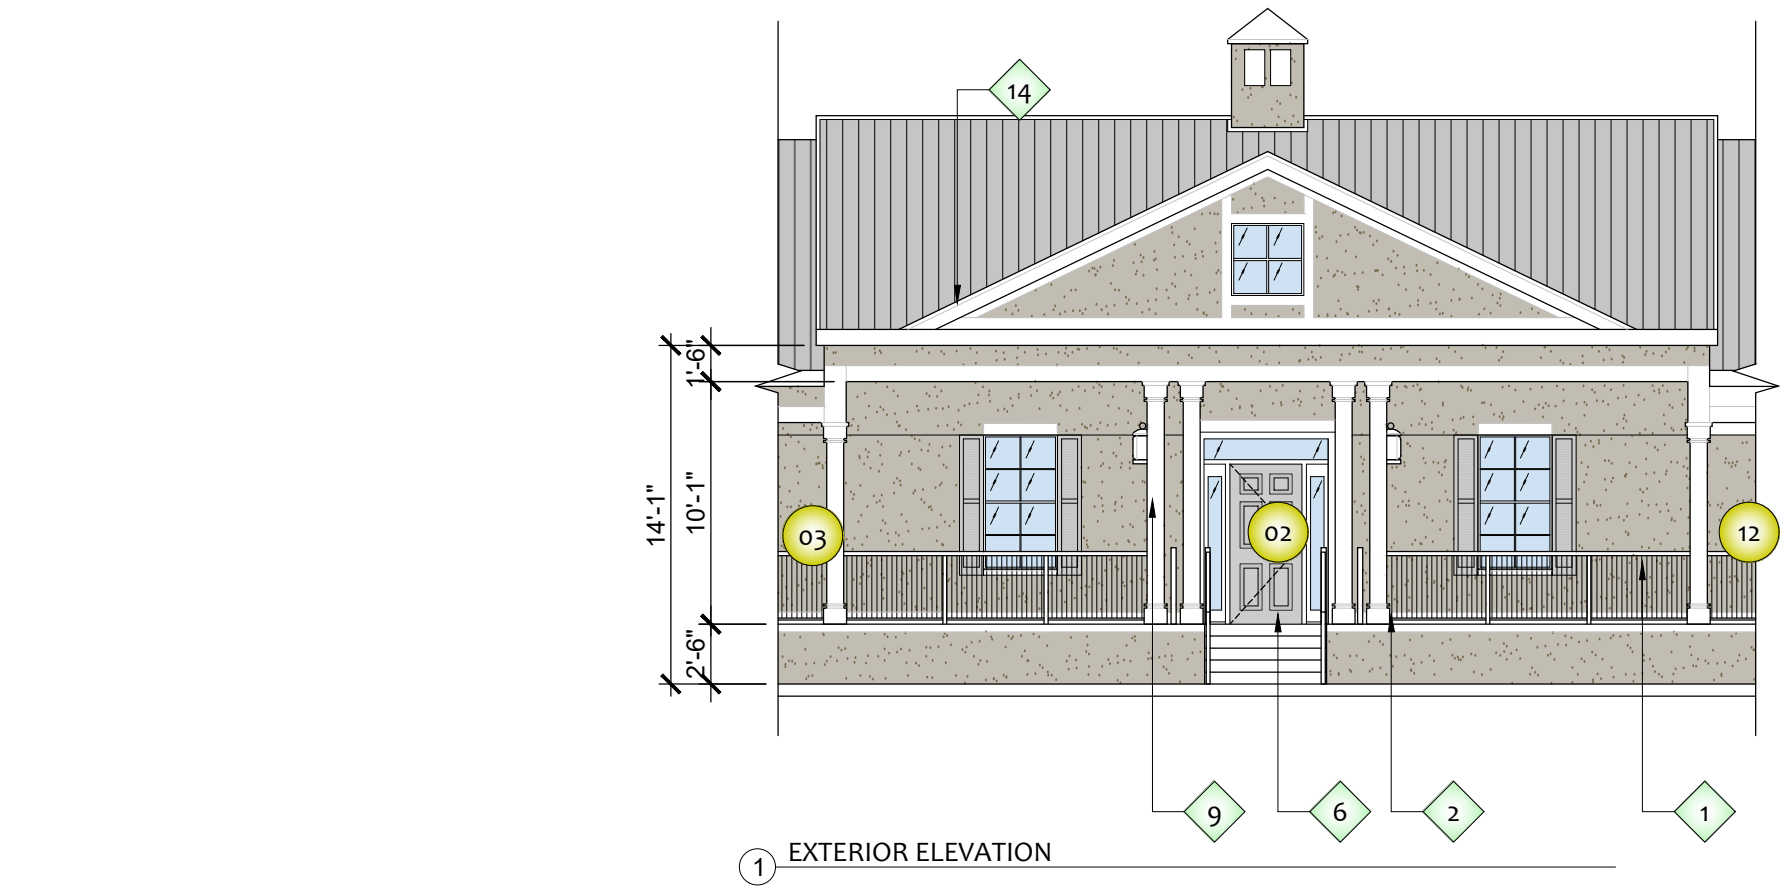


- | | | | | | |
|---|----------|----|--------------------|----|-------------------------------|
| 1 | STUCCO | 6 | ENTRY DOOR | 11 | TILE |
| 2 | WOOD | 7 | BUILDING SIGNAGE | 12 | METAL SIDING |
| 3 | BRICK | 8 | SIGNAGE ON GLAZING | 13 | ROOFING - SHINGLES |
| 4 | CONCRETE | 9 | LIGHT FIXTURE | 14 | ROOFING - STANDING SEAM METAL |
| 5 | CMU | 10 | STONE | 15 | ROOFING - TILE |

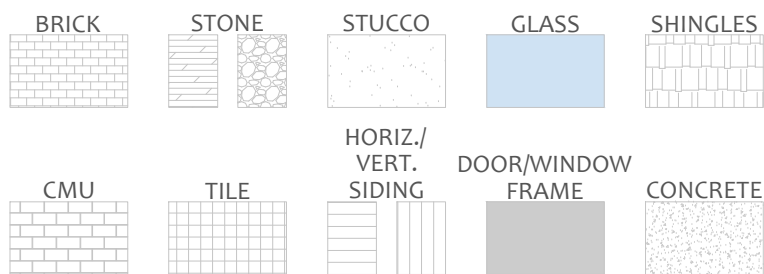

5' 10' 15'

SCALE: 1/8" = 1'-0"

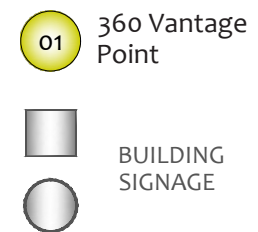

OWNER:

CLIENT:



Arktech Solutions LLC.
10804 Inside Loop
Orlando, FL 32825
tel: (214) 606-5281
www.Arktech.org

FC NAME: ----	
FCID: N/A	
FC ADDRESS: ----- ----- -----	
FIELD SURVEYOR: ----	
PROJECT DIRECTOR: ----	
CHECKED BY: ----	
DATE COMPLETED: 08-02-2017	
PROJECT NUMBER: ----	
SHEET: AX01	
DRAWING NUMBER: 10	OF: 6
DRAWING NAME: EXTERIOR ELEVATIONS	